


# CASE ERECTOR LEFT HAND / GLUE FLOOR PLAN

**E20G**

**E30G**

**CASE ERECTOR**

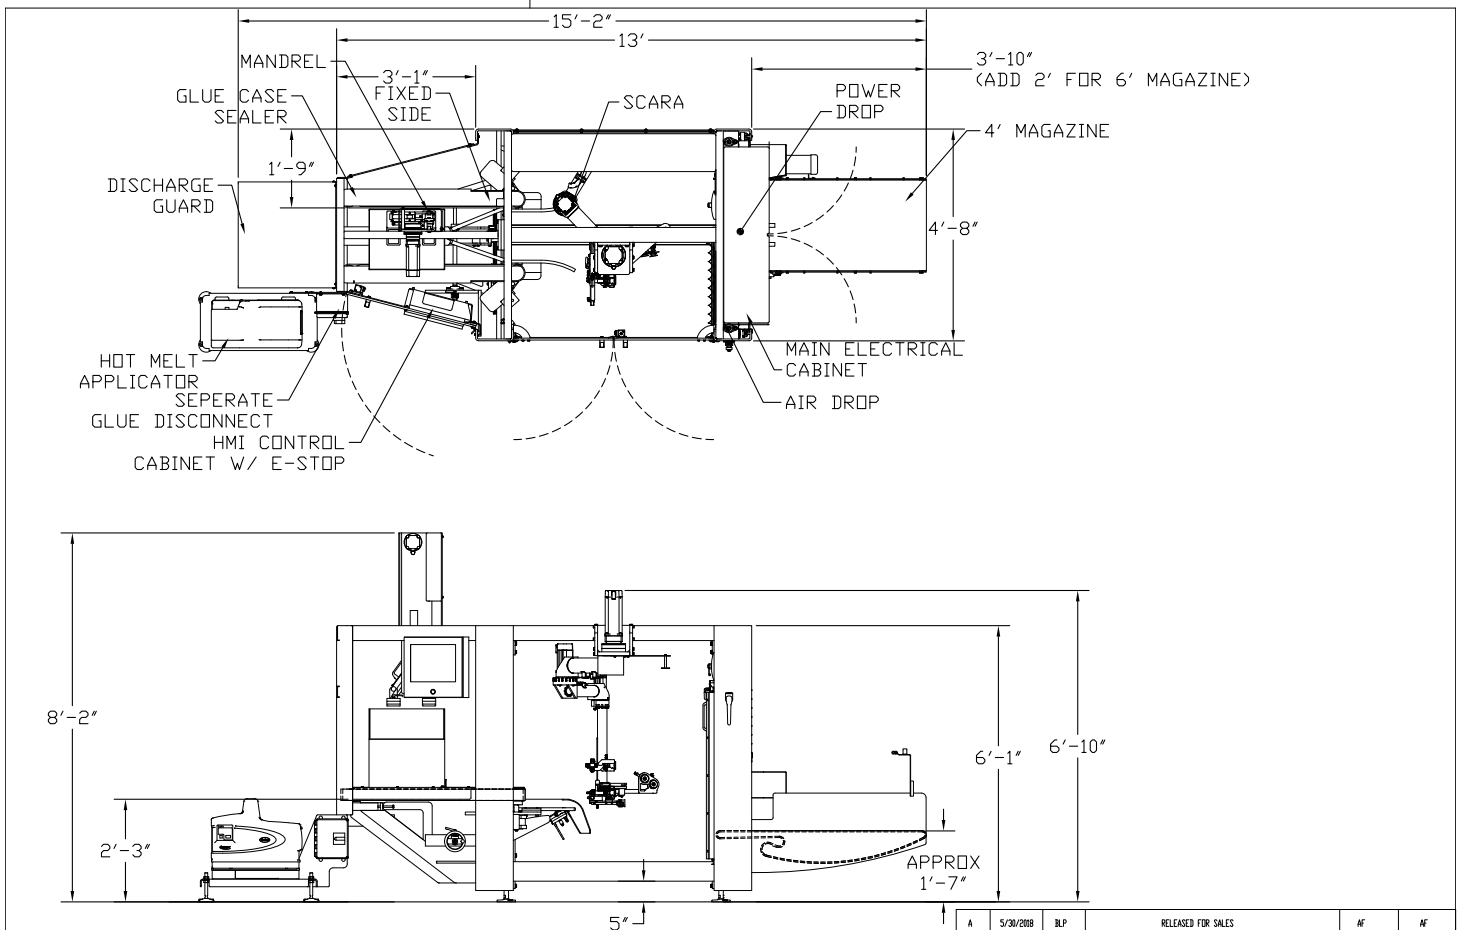

MACHINE SPECIFICATIONS	
MACHINE VOLTAGE	480V-3PH-60HZ
EST AMP LOAD	14 AMPS @ 480V
MAIN DISCONNECT	30 AMP FUSED 15 AMP
EST GLUE AMP LOAD	5 AMPS @ 480V
GLUE DISCONNECT	30 AMP FUSED 15 AMP
EST AIR USE	TBD SCFM @ 90PSI

NOTE - PRELIMINARY FLOOR PLAN FOR ORIENTATION OF BASE PRICE MACHINE ONLY, DIMENSIONS ARE SUBJECT TO CHANGE ACCORDING TO DESIGN REQUIREMENTS AND OPTIONS PURCHASED

A	5/30/2018	BLP	RELEASED FOR SALES	AF	AF
REV.	DATE	REVISED BY	CHANGE DESCRIPTION	REQUESTED BY	APPROVED BY
INSITE PACKAGING AUTOMATION			LH CASE ERECTOR WITH GLUE SEALER FLOOR PLAN		
DRAWN BY: BLP		CREATION DATE: 05/29/2018	SCALE: 1:24	PJM ID:	SHEET: 1 of 1
PROJECT NO: MXXXXXX		DWG SD: C	DRAWING NO: XXXXXFP		