


CASE ERECTOR RIGHT HAND / GLUE FLOOR PLAN

E20G

E30G

CASE ERECTOR

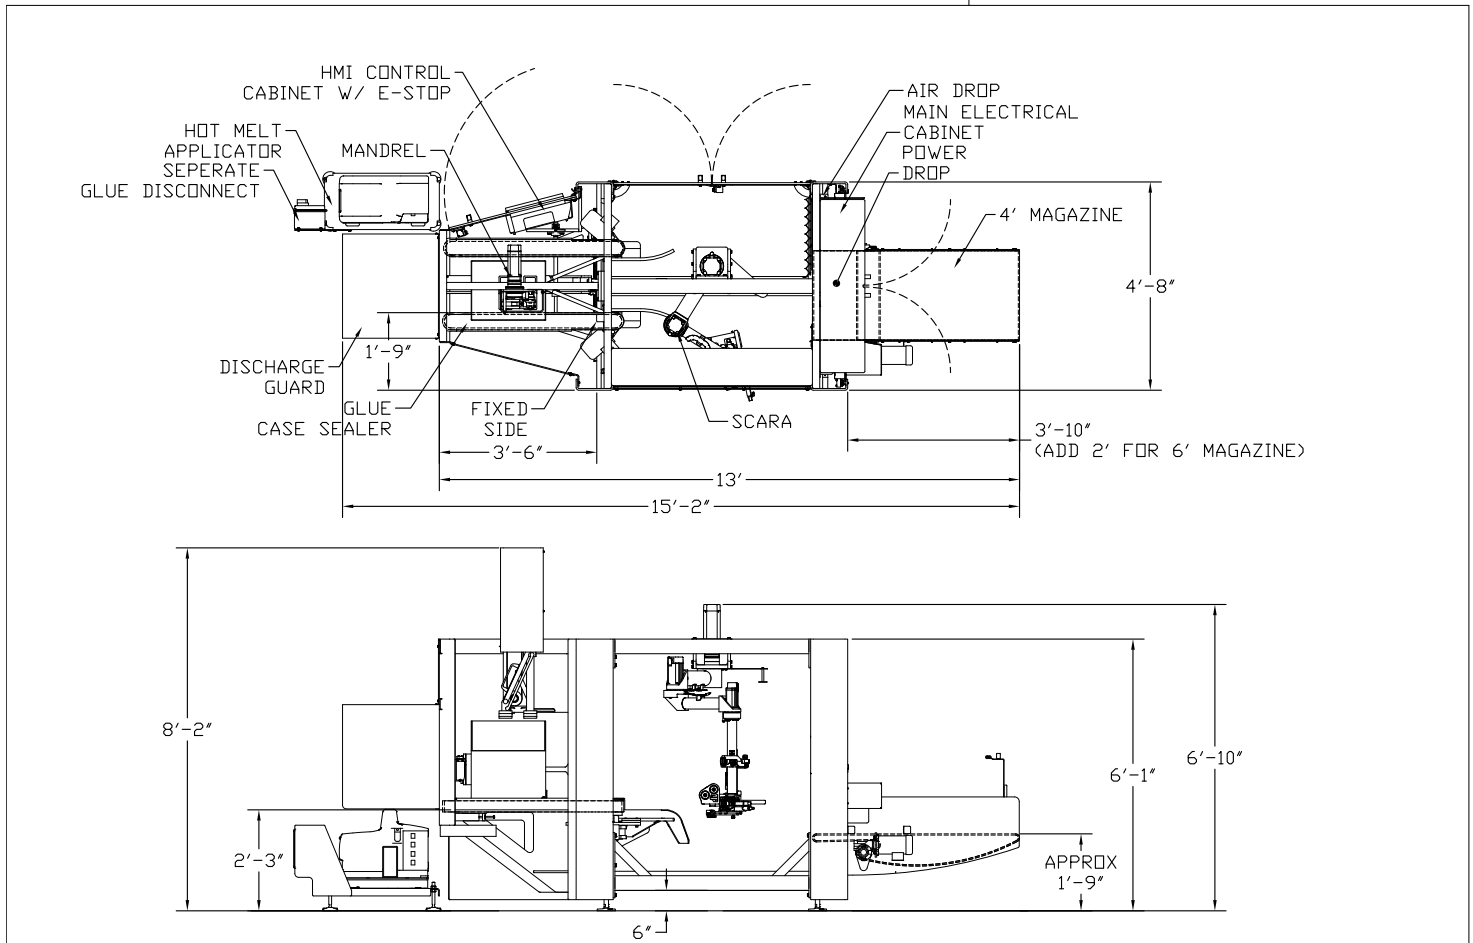

MACHINE SPECIFICATIONS	
MACHINE VOLTAGE	480V-3PH-60HZ
EST AMP LOAD	14 AMPS @ 480V
MAIN DISCONNECT	30 AMP FUSED 15 AMP
EST GLUE AMP LOAD	5 AMPS @ 480V
GLUE DISCONNECT	30 AMP FUSED 15 AMP
EST AIR USE	TBD SCFM @ 90PSI

NOTE - PRELIMINARY FLOOR PLAN FOR ORIENTATION OF BASE PRICE MACHINE ONLY, DIMENSIONS ARE SUBJECT TO CHANGE ACCORDING TO DESIGN REQUIREMENTS AND OPTIONS PURCHASED

REV.	DATE	REVISED BY	CHANGE DESCRIPTION	REQUESTED BY	APPROVED BY
A	5-30-2018	BLP	RELEASED FOR SALES	AF	AF

INSITE PACKAGING AUTOMATION		DRAWING NAME: RH CASE ERECTOR WITH GLUE SEALER FLOOR PLAN			
DRAWN BY: BLP	CREATION DATE: 05/29/2018	SCALE: 1:24	P/W L/D:	SHEET: 1 of 1	
PROJECT NO: MXXXXXX	DWG SZ: C	DRAWING NO: XXXXXXFP			

This drawing and the information contained is the sole property of Douglas Machine Inc. It is not to be used, copied, reproduced, or distributed in whole or in part without the prior written consent of Douglas Machine Inc.