


CASE ERECTOR LEFT HAND / TAPE FLOOR PLAN

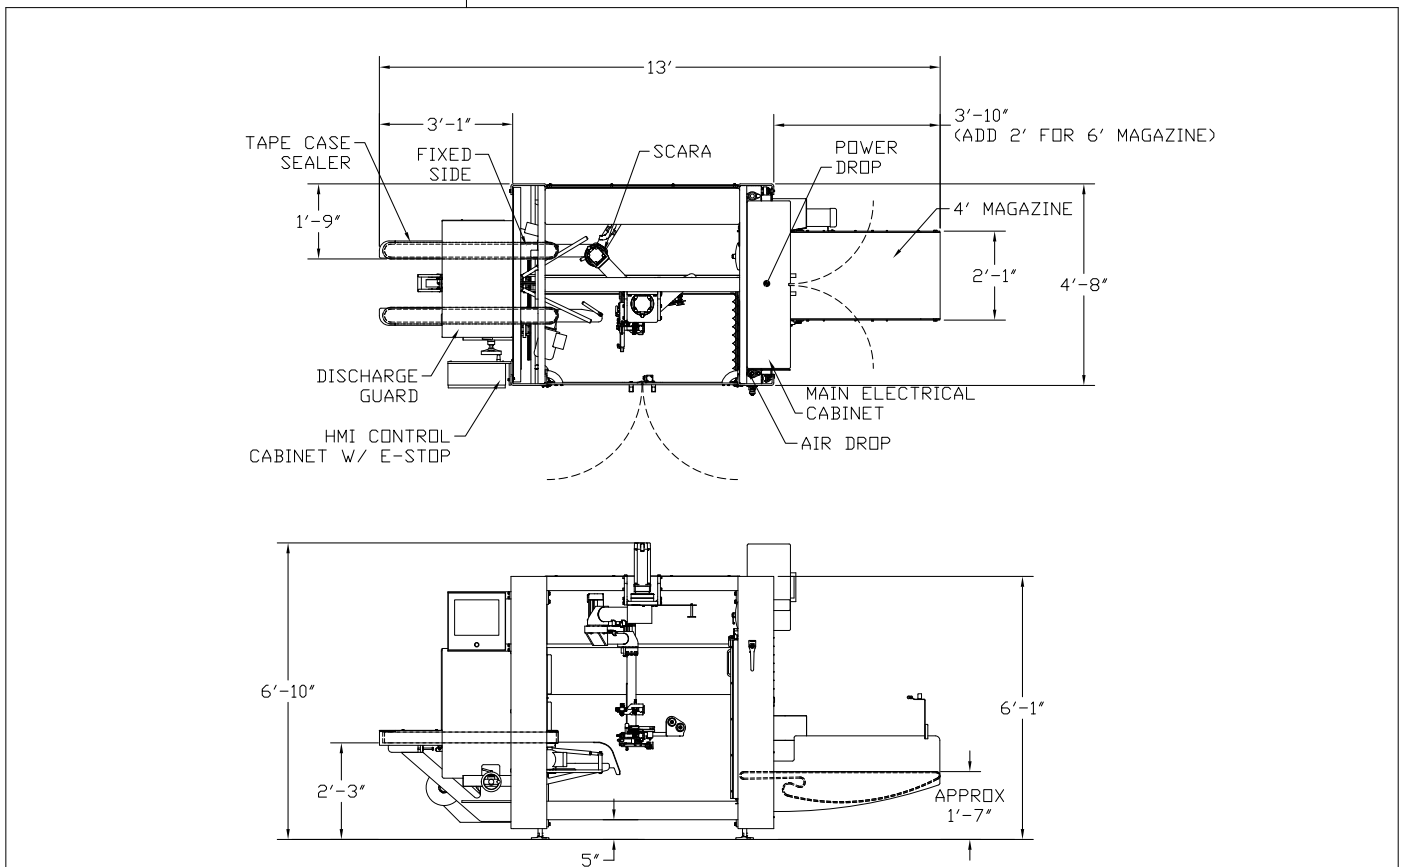

CASE ERECTOR



MACHINE SPECIFICATIONS	
MACHINE VOLTAGE	480V-3PH-60HZ
EST AMP LOAD	12 AMPS @ 480V
MAIN DISCONNECT	30 AMP FUSED 15 AMP
EST GLUE AMP LOAD	NA AMPS @ 480V
GLUE DISCONNECT	XX AMP FUSED XX AMP
EST AIR USE	TBD SCFM @ 90PSI

NOTE - PRELIMINARY FLOOR PLAN FOR ORIENTATION OF BASE PRICE MACHINE ONLY, DIMENSIONS ARE SUBJECT TO CHANGE ACCORDING TO DESIGN REQUIREMENTS AND OPTIONS PURCHASED

REV.	DATE	REVISED BY	CHANGE DESCRIPTION	REQUESTED BY	APPROVED BY
A	5-30-2018	BLP	RELEASED FOR SALES	AF	AF

DRAWING NAME:		LH CASE ERECTOR WITH TAPE SEALER FLOOR PLAN			
DRAWN BY:	CREATION DATE:	SCALE:	P/W L/D:	SHEET:	
BLP	05/30/2018	1:24		1 of 1	
PROJECT NO:	DWG NO:	DRAWING NO:			
MXXXXXX	C			XXXXXXFP	

This drawing and the information contained is the sole property of Douglas Machine Inc. It is not to be used, copied, reproduced, or distributed in whole or in part without the prior written consent of Douglas Machine Inc.